



Calculation Summary							
Label	CalcType	Units	Avg	Max	Min	Avg/Min	Max/Min
HARRY BARBERIAN LANE CENTRELINE	Illuminance	Lux	36.40	82.9	0.2	182.00	414.50
LOADING DOCK ENTRANCE	Illuminance	Lux	87.49	145.0	47.1	1.86	3.08
PARKING ELEVATOR ENTRANCE	Illuminance	Lux	128.45	182.8	66.8	1.92	2.74
PEDESTRIAN WALKWAY - EAST	Illuminance	Lux	61.51	186.5	0.4	153.78	466.25
PEDESTRIAN WALKWAY - ELM ST	Illuminance	Lux	49.64	239.1	0.4	124.10	597.75
PROPERTY LINE	Illuminance	Lux	39.21	149.2	0.3	130.70	497.33

Luminaire Schedule								
Symbol	Qty	Label	Arrangement	LLF	Description	Tag	[MANUFAC]	BUG Rating
□	4	LF_Typology_Path_CQ501-008L5	SINGLE	0.900	BOLLARD LUMINAIRE	LA	Landscape Forms Inc	B0-U2-G0
□	7	121-16L-1200-WW-G4-4	SINGLE	0.900	WALL PAC	LB	SIGNIFY GARDCO	B1-U0-G2

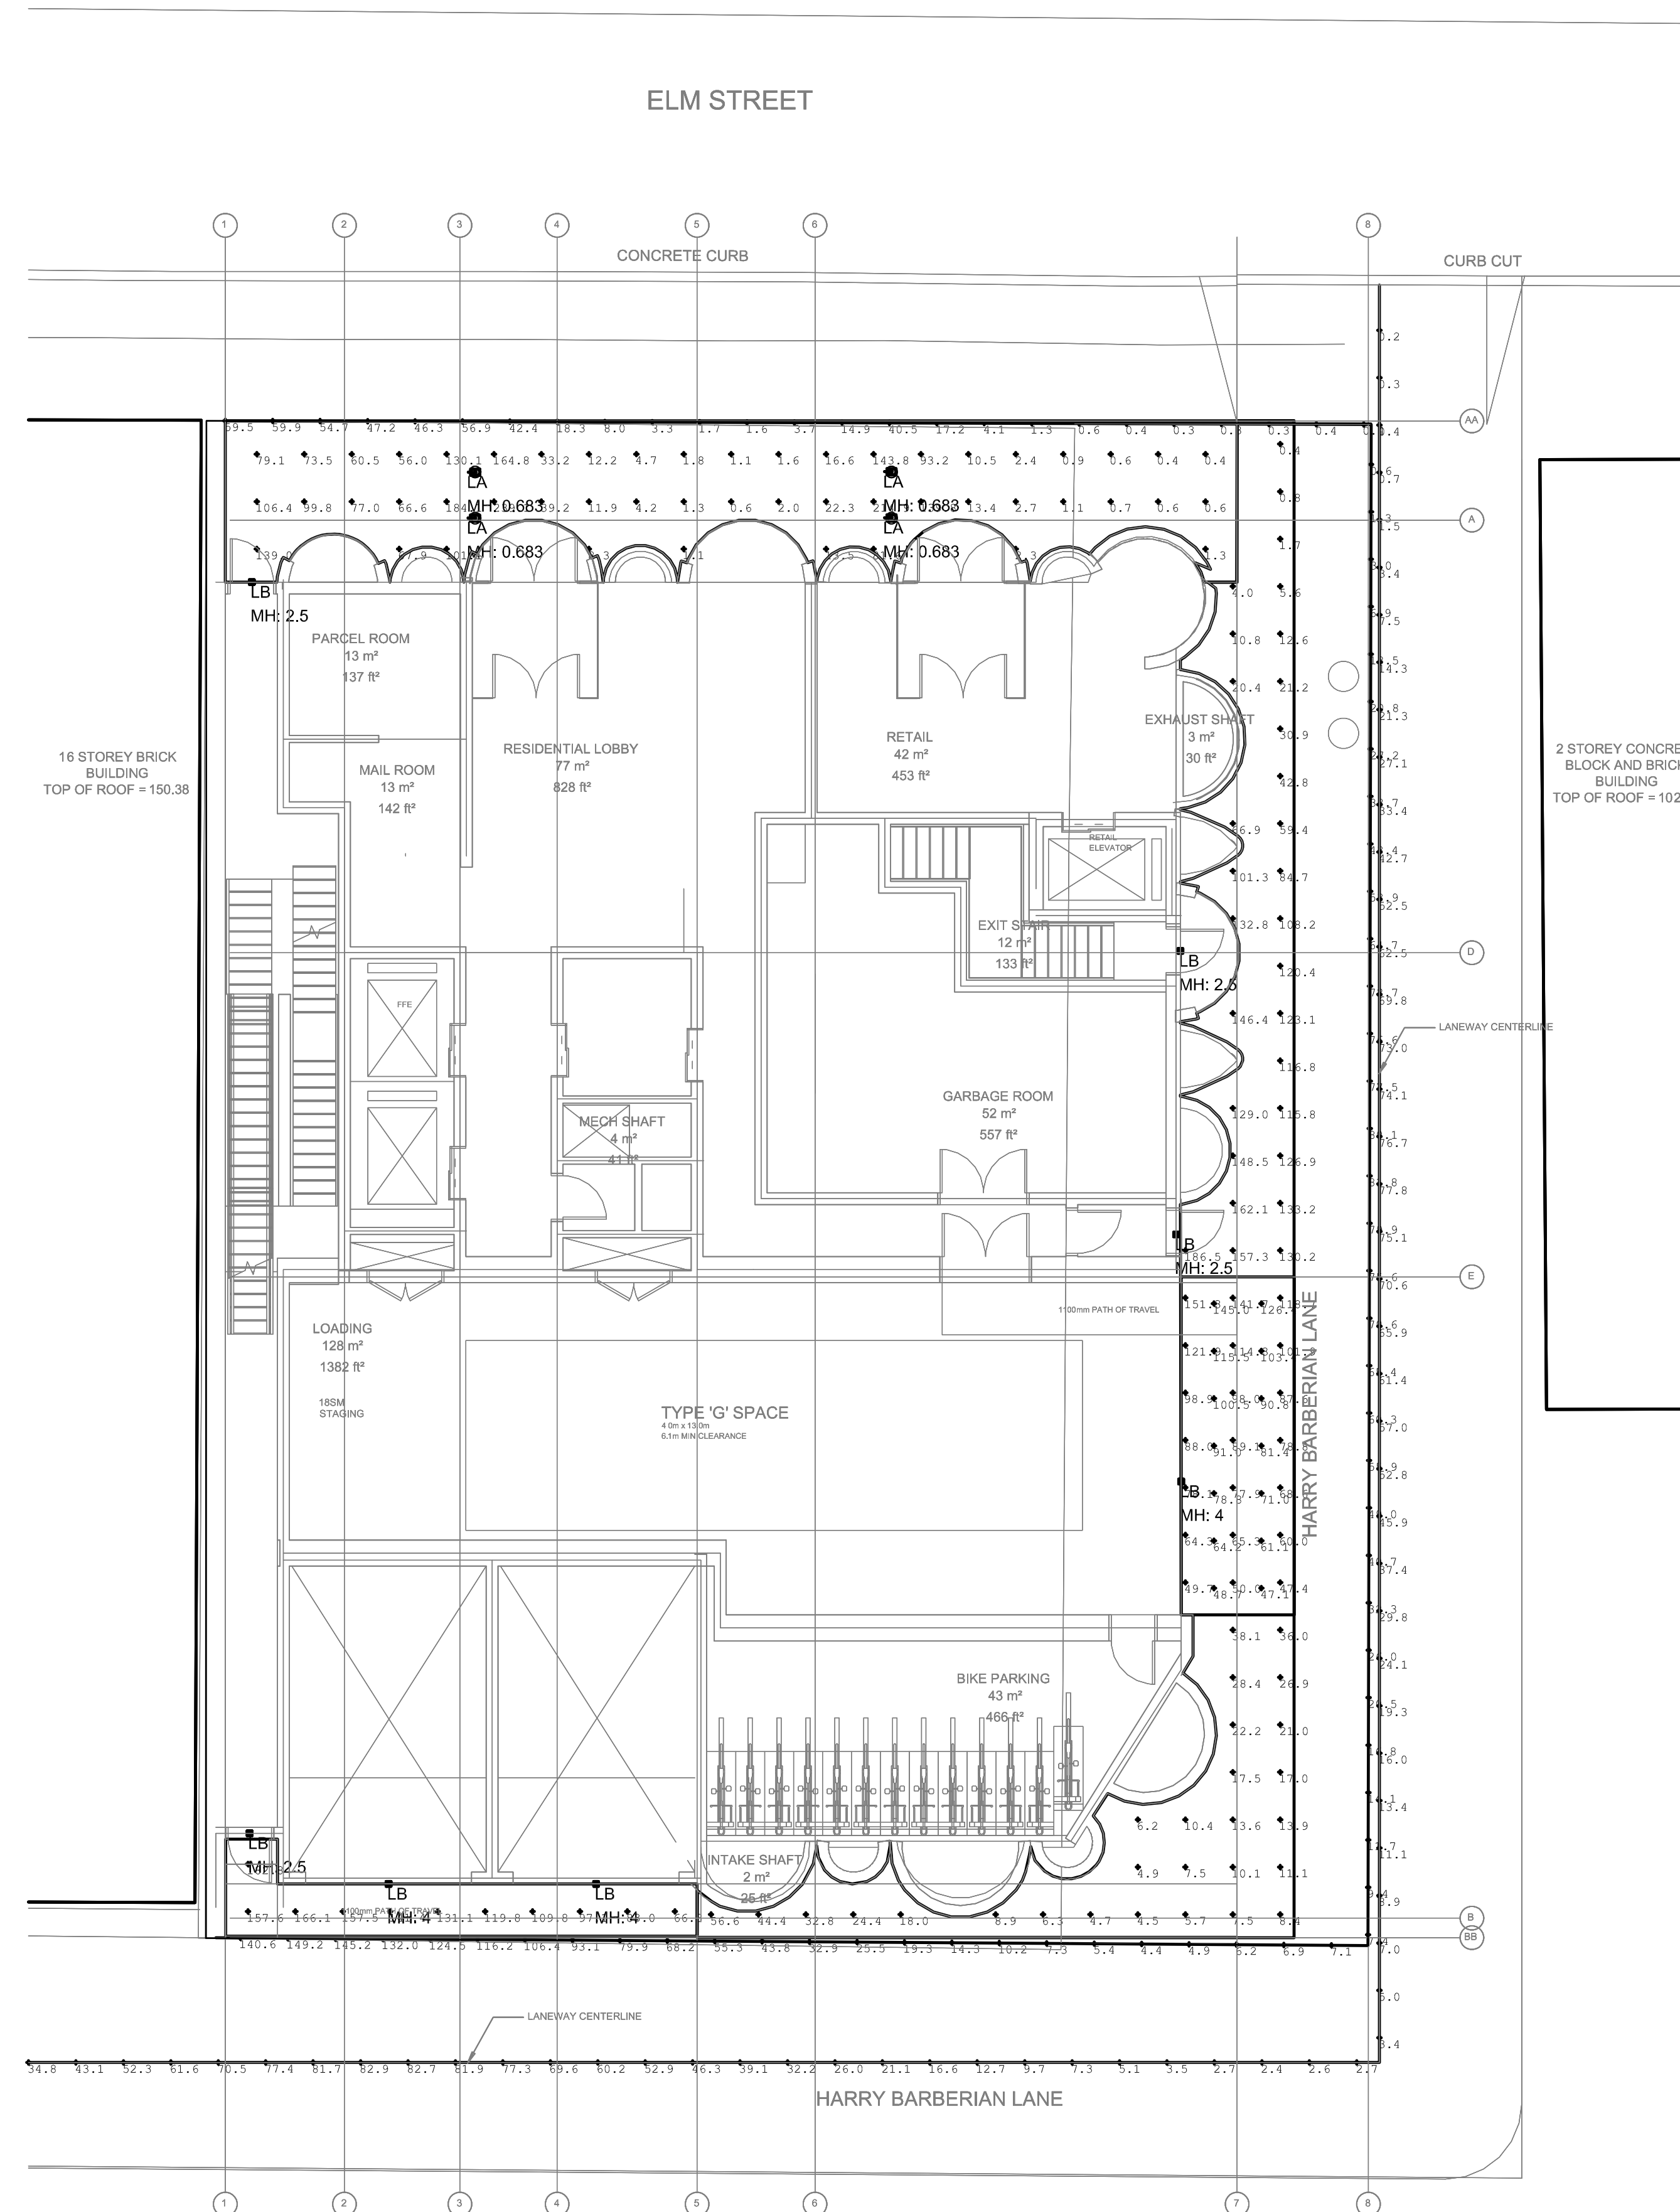

SP#
Permit
Tender
Contract
Construction
No.
DESCRIPTION
Date

NOT FOR CONSTRUCTION

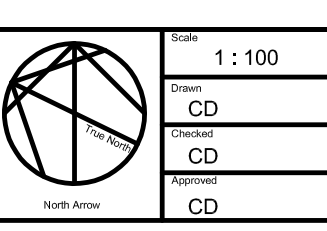

Client  
**Fora Developments**

Project  
**15-17 ELM STREET**

Project Address  
950 Dupont Street  
Toronto, On,  
Canada, M9H 1Z2

Drawing Title  
**SITE PLAN - PHOTOMETRICS**

Project Number  
**22018**

Drawing Number  
**E0-01**